


Drawing Legend

Electrical	
	Distribution Board
	Electrical Inlet
	Double 13Amp Socket (450mm AFFL)
	20A Double Pole Lightswitch (1200 AFFL)
Heating	
	Panel Heater
Lighting	
	L.E.D Batten Light

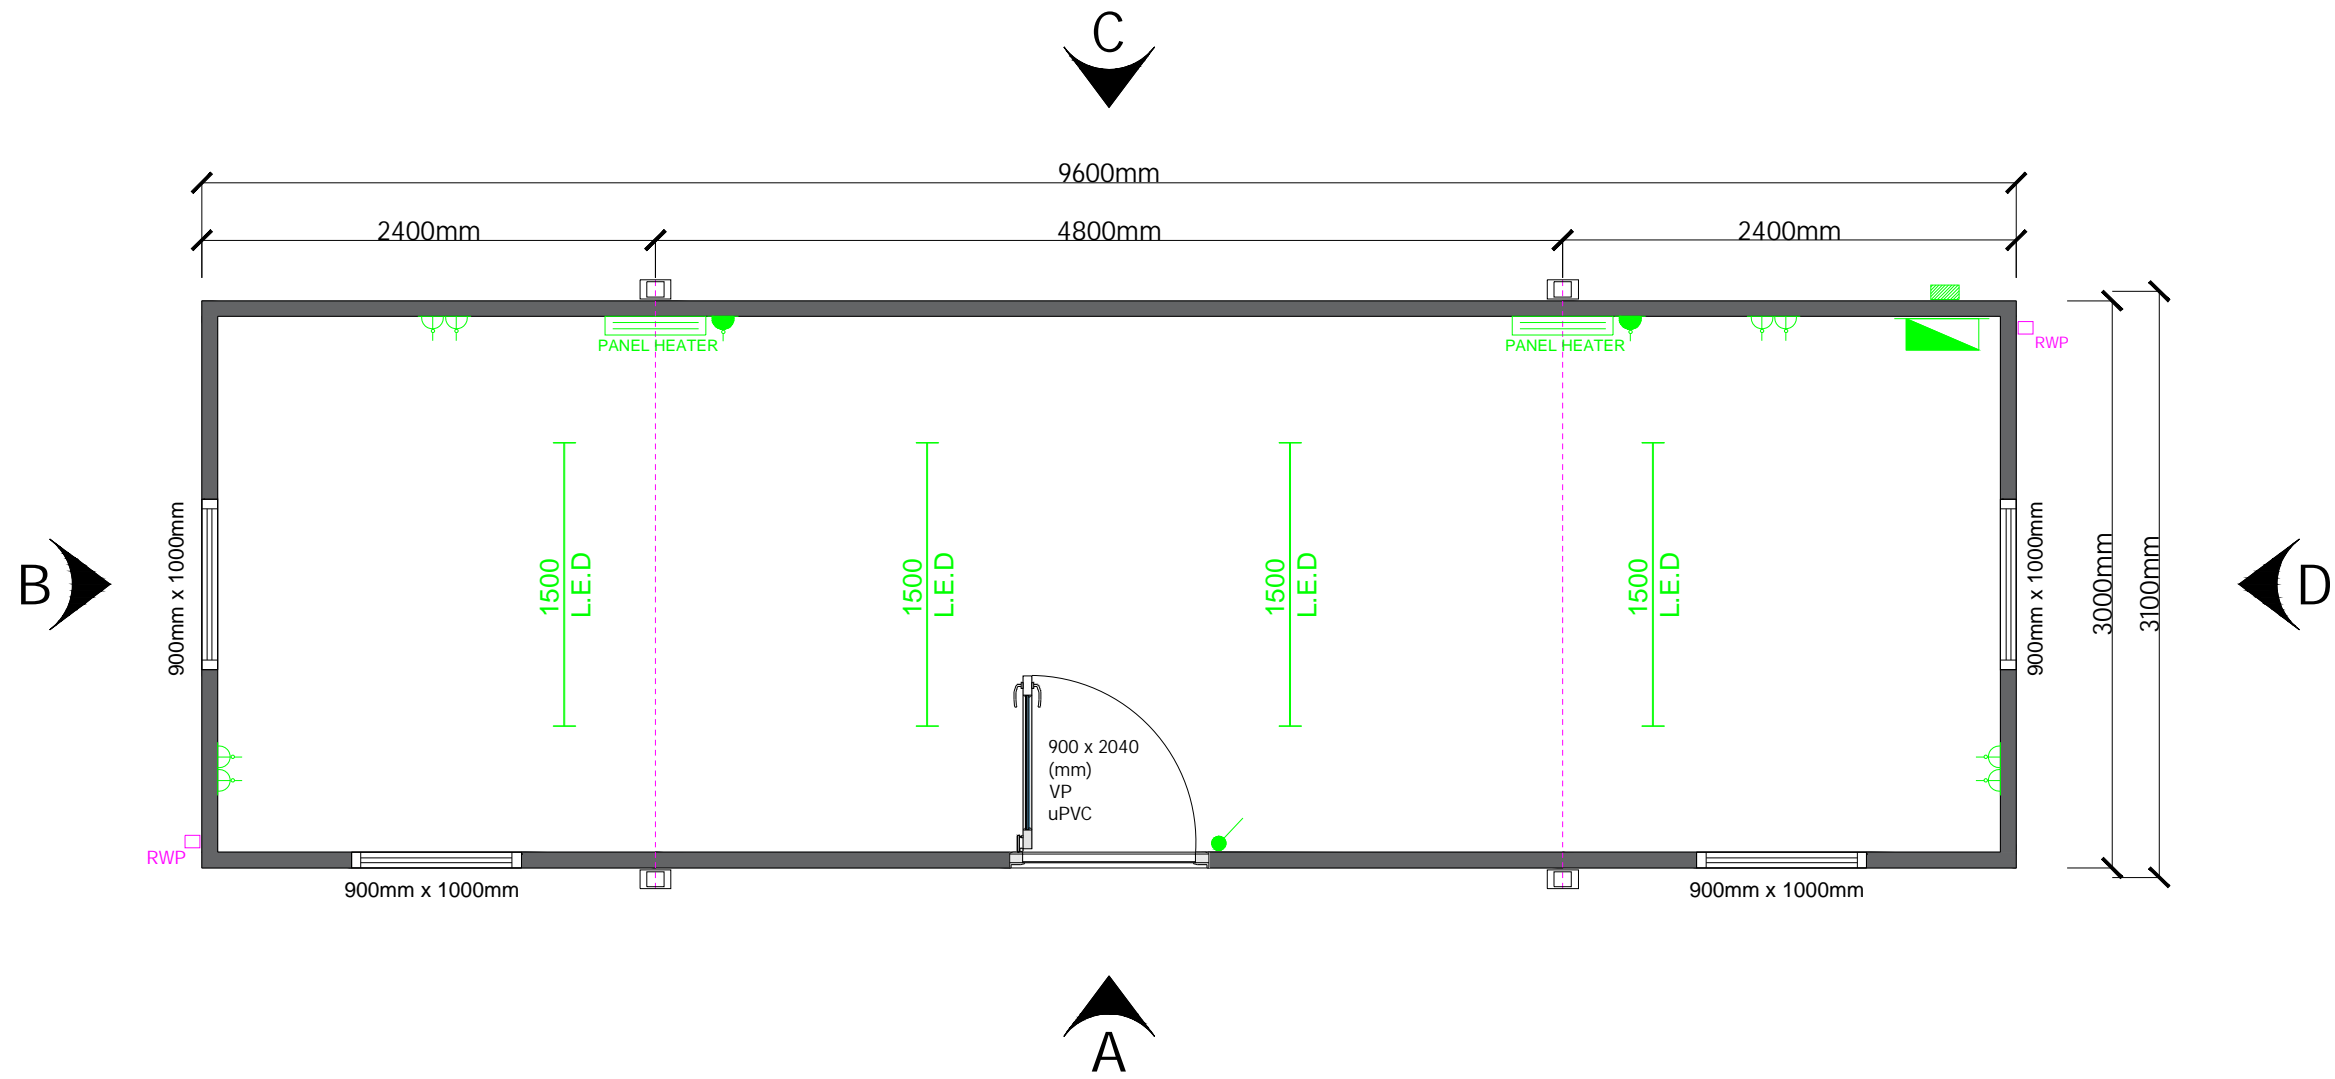

REV	DATE	DESCRIPTION	By



Project:			
32 x 10 A Cabin (9.6m x 3m)			
Drawing:			
Floor Plan			
Drawn By:	Date:		
B.W	11/10/24		
Checked By:	Sheet:	Scale:	
	A3	1:40	
Drawing Number:	Rev:	Stock Reference:	

This drawing is to be read in conjunction with all related drawings. Do not scale from this drawing. All dimensions must be checked and verified on site before commencing any work or producing shop drawings. The originator should be notified immediately of any discrepancy. This drawing is copyright and remains the property of New Cabin Space Ltd.